











01 02 03 04 05 06 07 08

CRASH BARRIER

LEGEND	
	25 MM Conduit
	Photo cell
	Push Button
	4 Core 1.5 sq mm
	5 Core 2.5 sq mm
	6 Core 1 sq mm
	1 Core 1.5 sq mm
	4 Core 1.5 sq mm

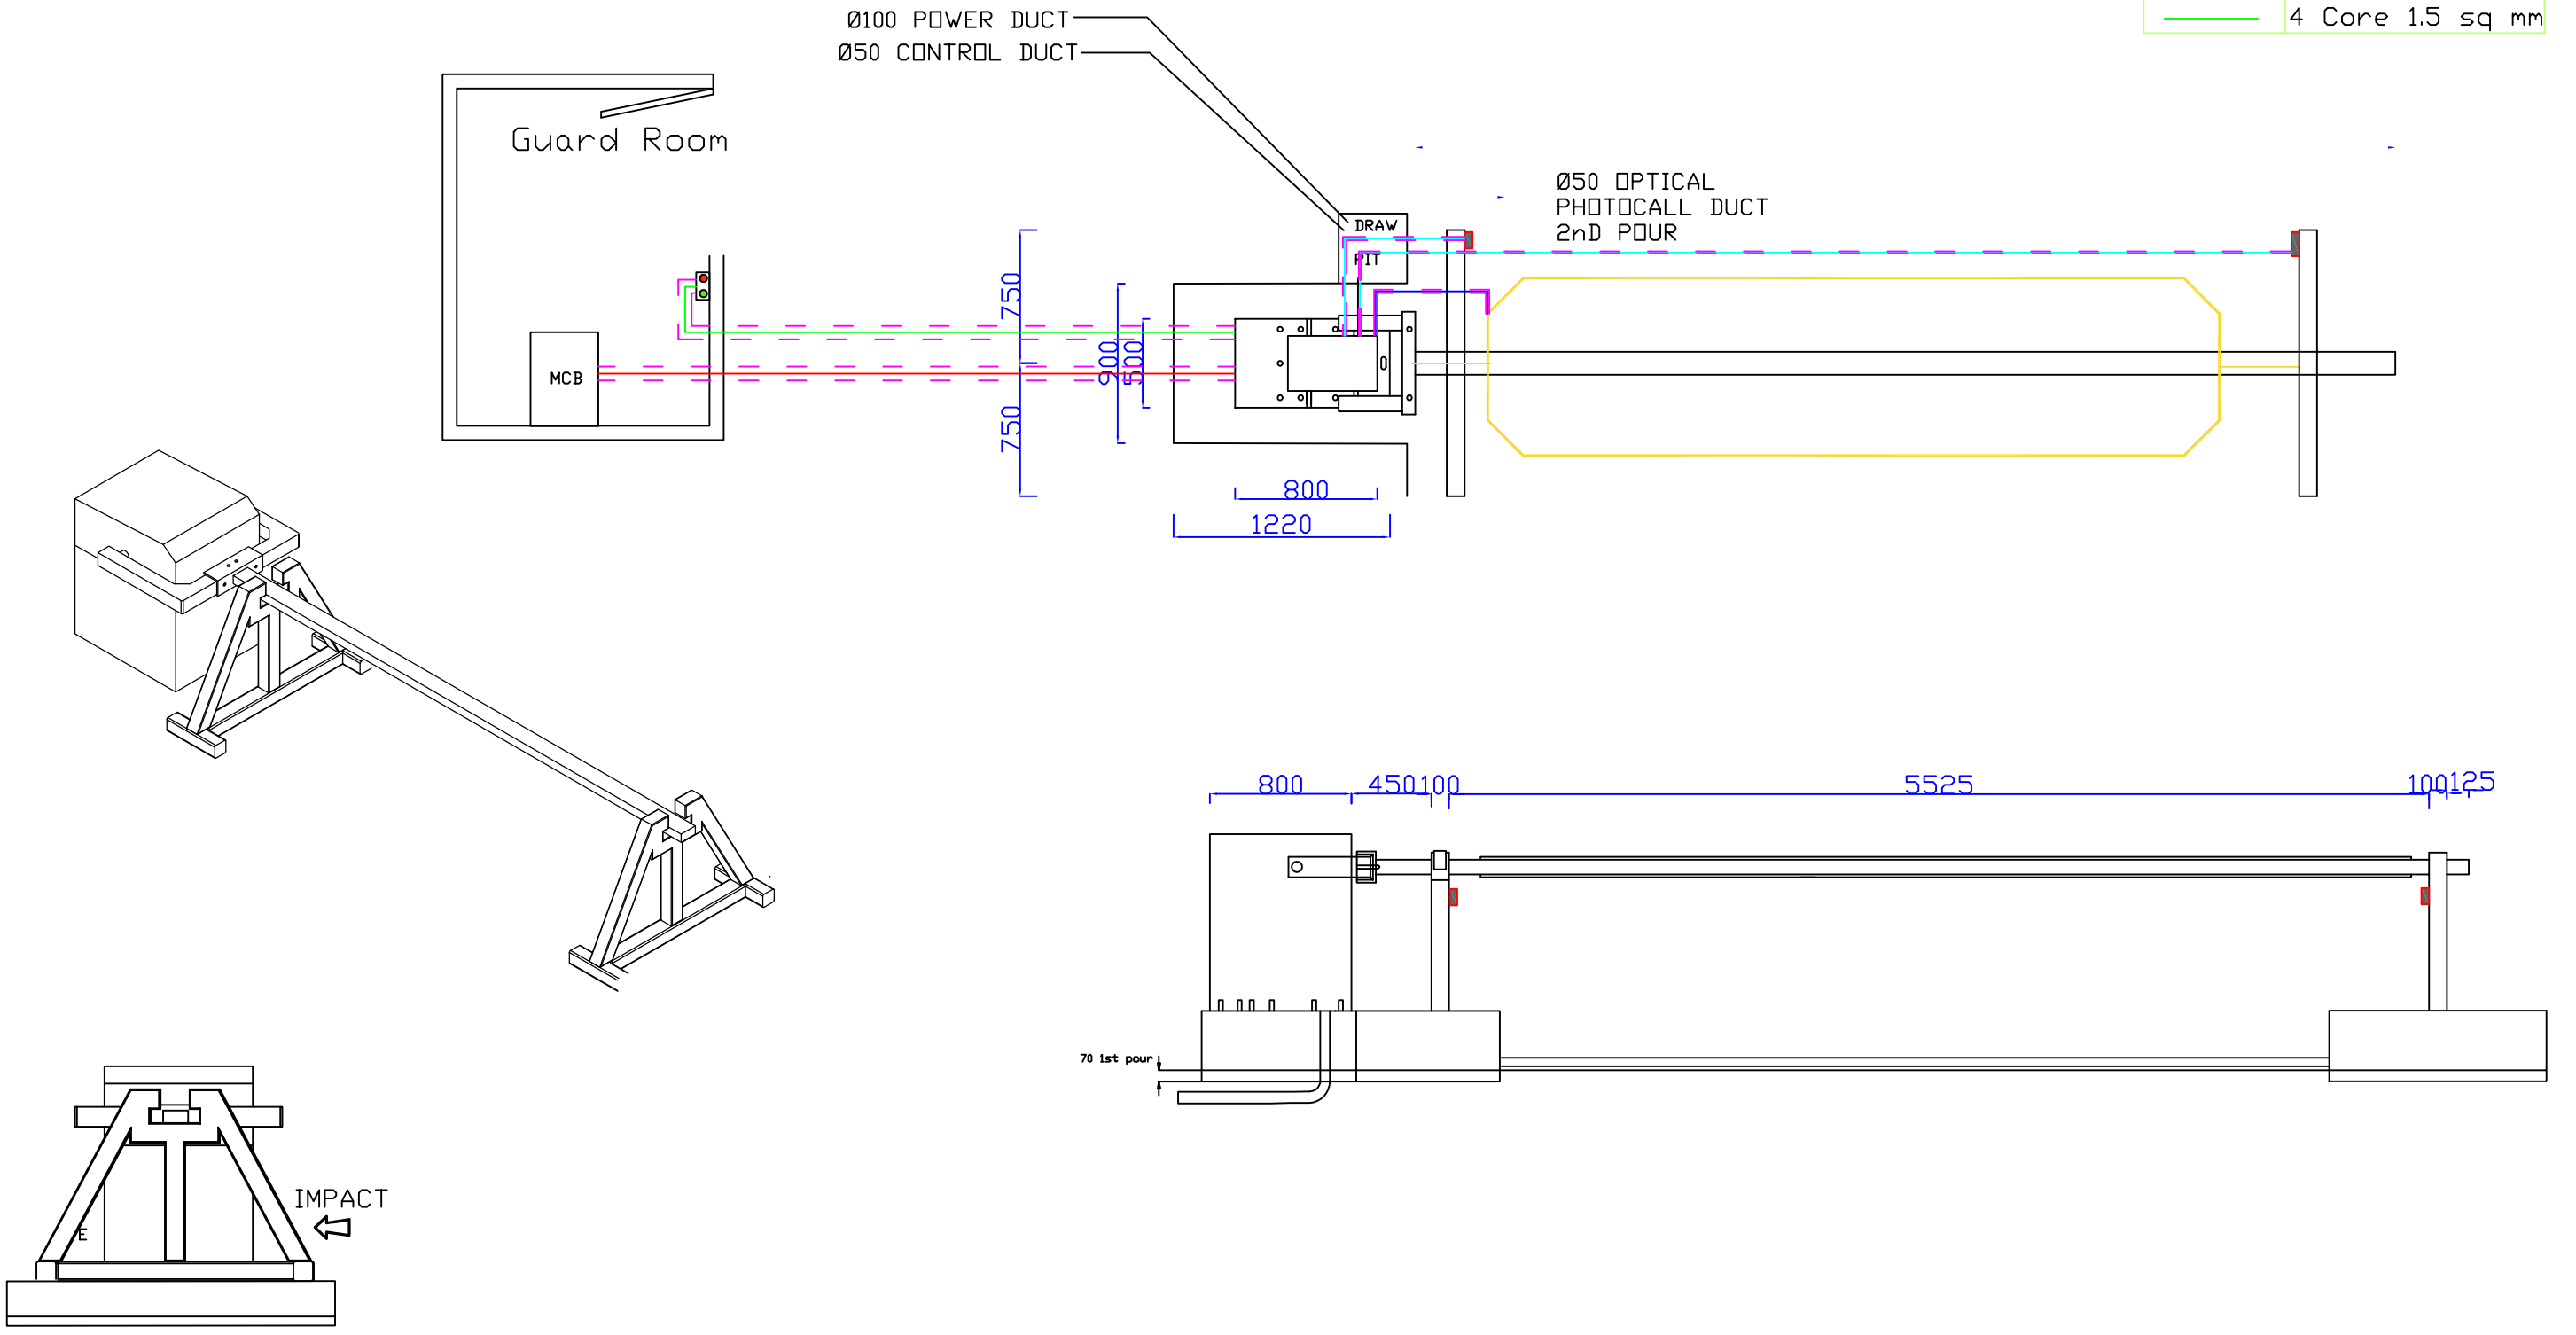

a) Revisions: -				b) Manufactured by		c)		d)			
Project: - SLD For Reference	Consultant: -	Architect: -	Contractor: -	 NEPTUNE AUTOMATIC PVT LTD A-11, SECTOR-59, NOIDA-201301		Client: -		Drawn	Priya		
						Detail: - SINGLE LINE DIAGRAM		Scale	N.T.S.	REV.	00
						Checked By: - MM		Date	03/09/2021	SHEET NO.	01
								NO.OF SHEET	01		